



SECTION @ A-A



ELECTRICAL LEGEND

	20" x 20" LED lights
	22w LED Fittings
	15w - 16w Hybec Light Fittings
	40" tube light in pantry / canteen
	20" tube light above wash basin
	Exhaust fan

CONCEPTUAL LAYOUT - 16 (LIGHTING LAYOUT PLAN)
FIRST FLOOR

PROPOSED CONCEPTUAL INTERIOR LAYOUT FOR



BANK OF BARODA

RELATIONSHIP MANAGEMENT HUB ,
1st Floor, Kedy Shopping Arcade, 233-234, Bellasis Road, Nagpada, Mumbai Central, Mumbai - 400008

NOTE :-

1. Architect reserves the right to make slight modifications in the dwgs.as per the site conditions.
2. No changes shall be made without the consent of the Architect.
3. The information in the drawings supercedes all other documentation.
4. The Architect reserves a copyright to the drawing and the same shall not be used elsewhere.

PROJECT : COMMERCIAL PROJECT

DWG. TYPE : INTERIOR DWGS.

TITLE : REVISED LAYOUT PLAN-16

OPTION : 01

REV. : 01

DATE : 04-08-2021


SCALE : N.T.S

DWG.NO : 16

DRAWN BY : KIRTAN PATEL

CHECKED BY : Ac.PANKAJ LAD

THIS DRAWING IS THE PROPERTY OF SARAYAN TUTNKEY SOLUTIONS AND IS NOT TO BE REPRODUCED/ COPIED/HANDED OVER TO A THIRD PARTY OR USED FOR ANY OTHER PURPOSE THAN THAT FOR WHICH IT HAS BEEN LOANED.

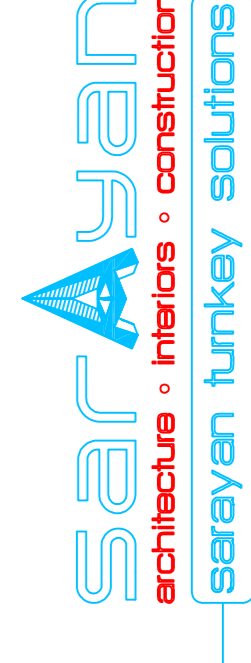

703, D'SOUZA MANSION, J.S.ROAD,DAHISAR-WEST MUMBAI- 400 068.
Telefax : 022 - 28956520 .Email -pladarchitects@yahoo.in